 



THE UNIVERSITY OF IOWA - LOCATION MAP


Relocate Football Practice Facility/Lot 43 Expansion





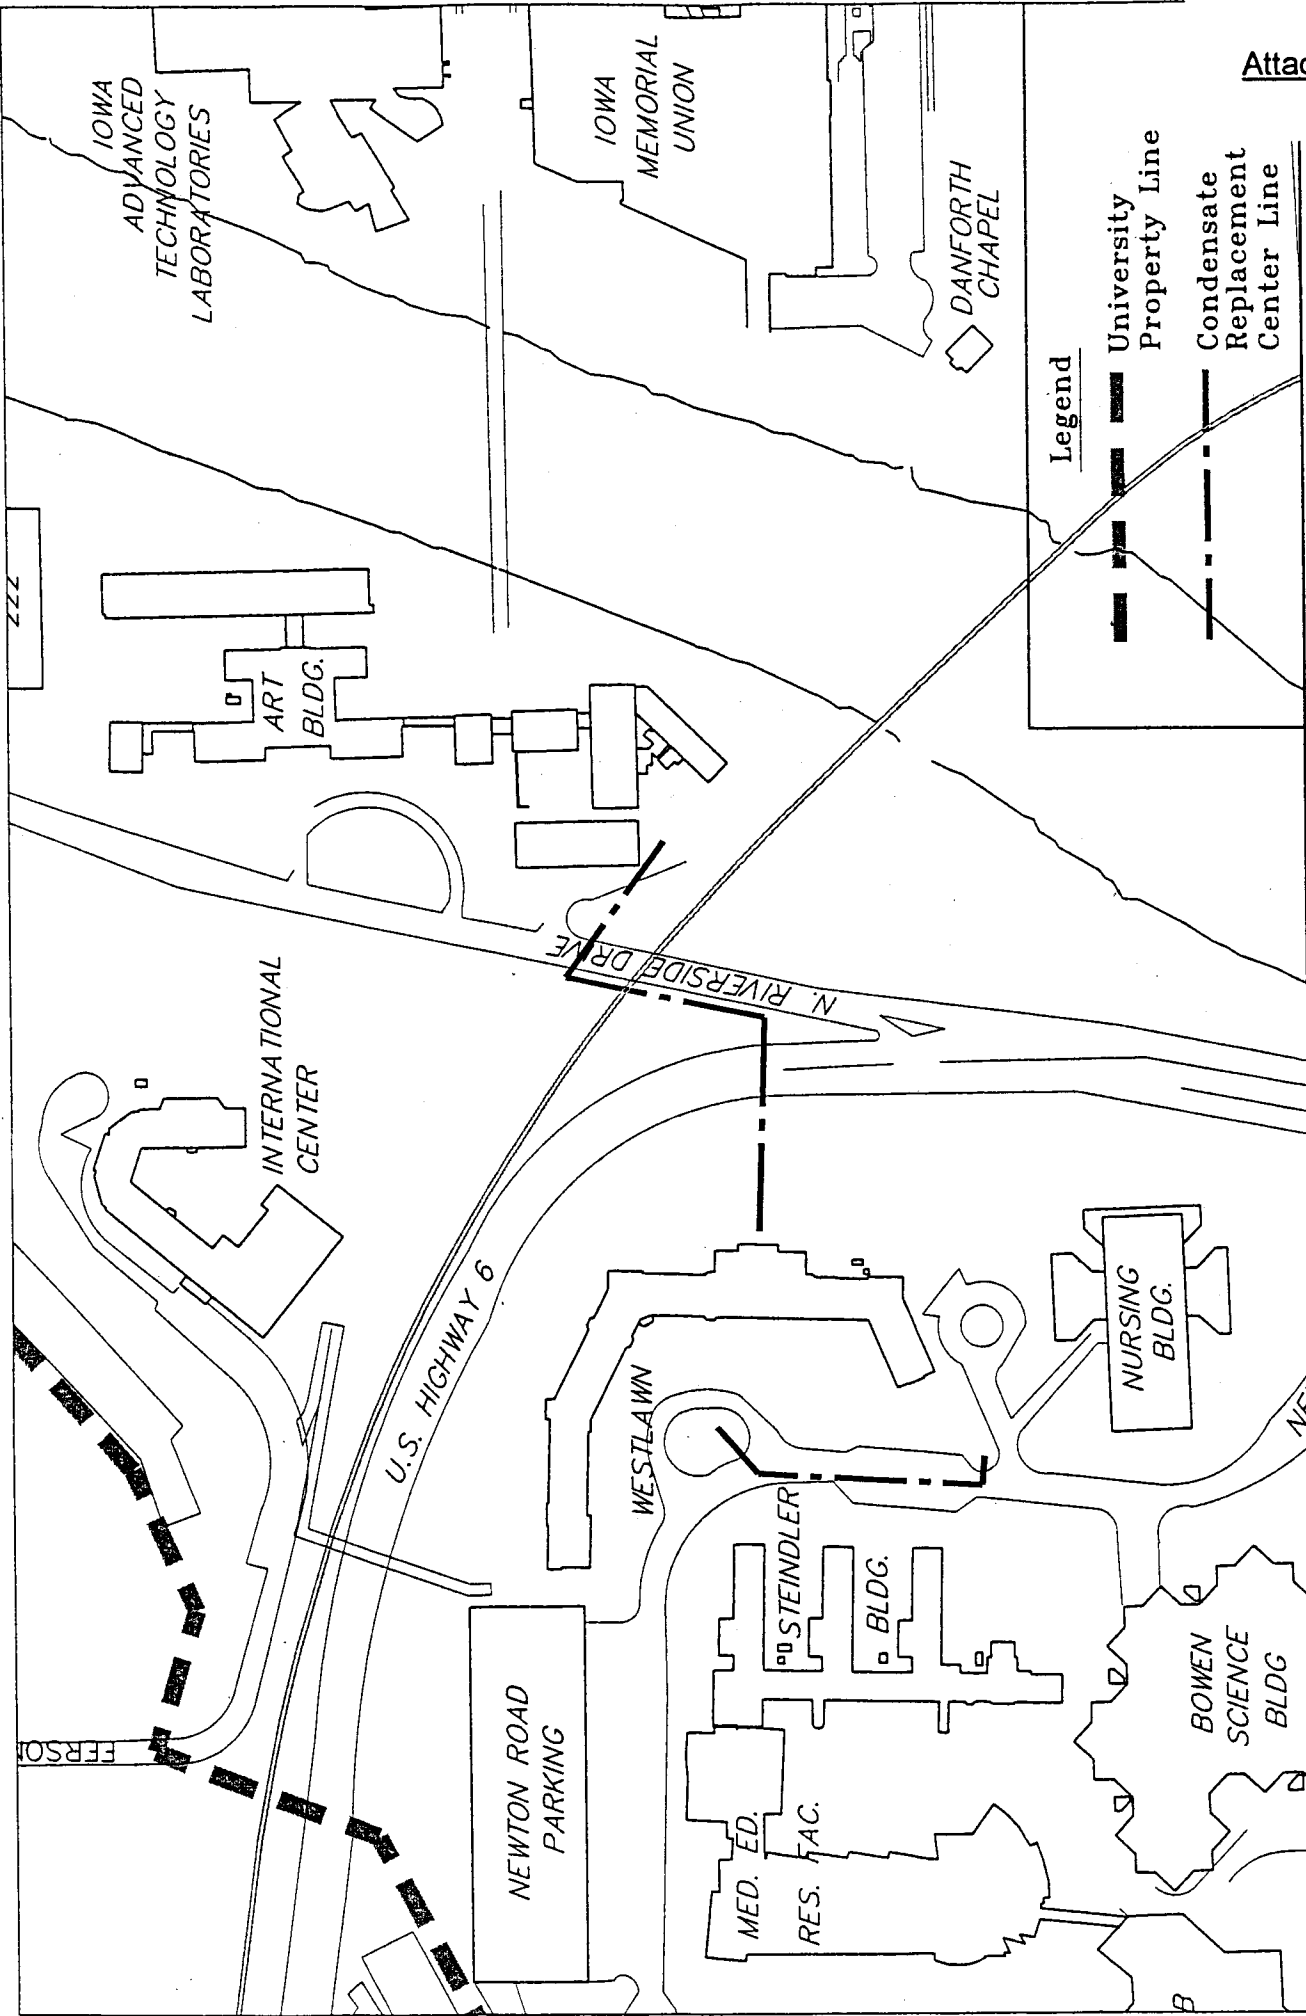


THE UNIVERSITY OF IOWA - LOCATION MAP

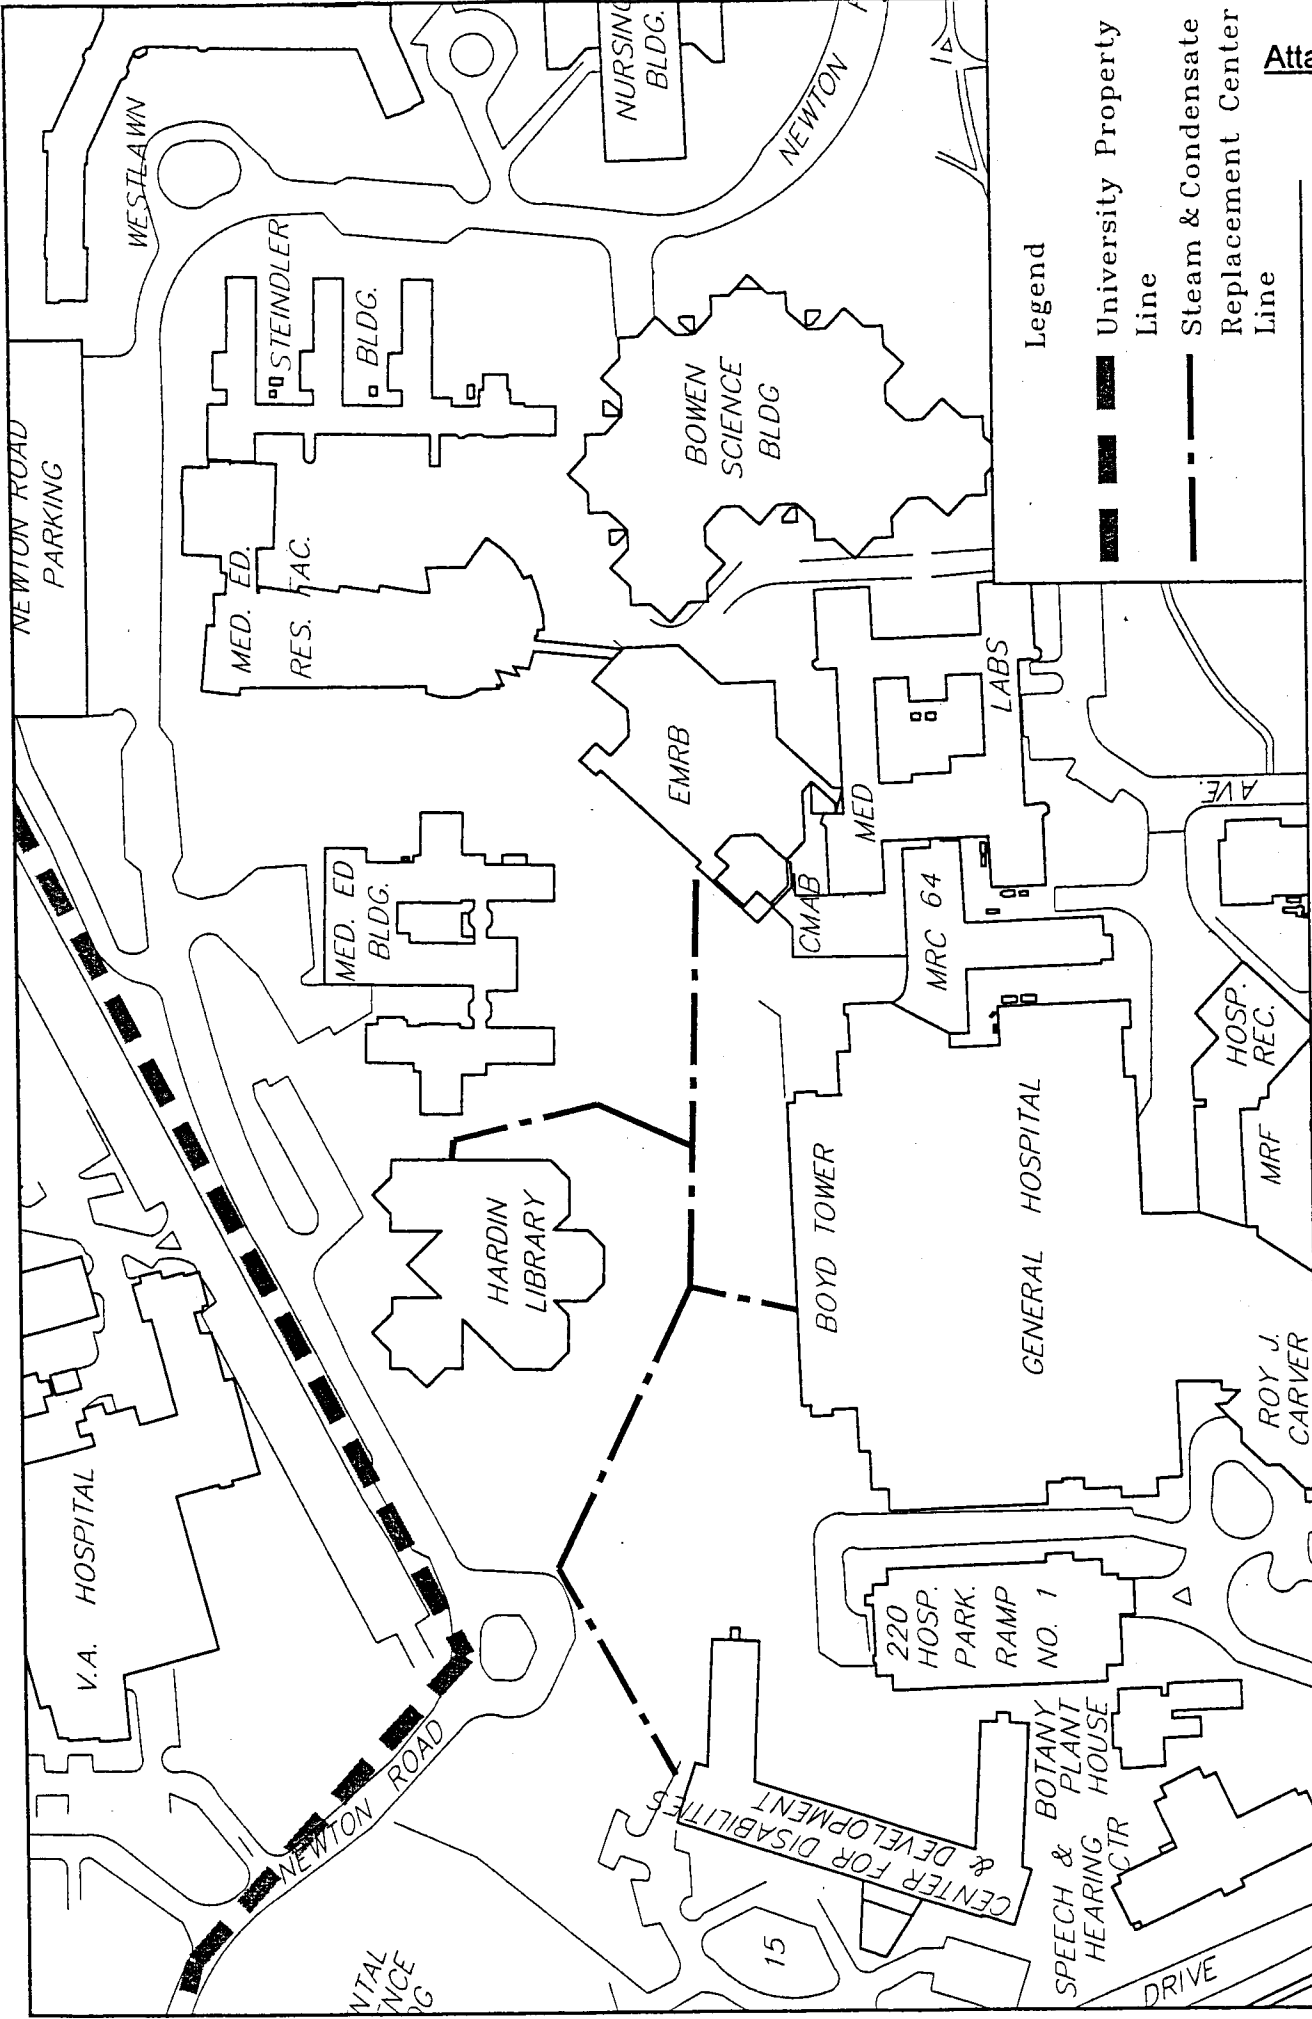West Campus - Replace Condensate Piping



**Legend**

-  University Property Line
-  Steam & Condensate Replacement Center Line
-  Center Line

THE UNIVERSITY OF IOWA - LOCATION MAP

Health Sciences Campus - Replace Steam & Condensate Piping




**Project Name:**  
**BOWEN**  
**SCIENCE**  
**BUILDING**  
 Remodeling  
 for  
**Biochemistry**  
**THE UNIVERSITY**  
**OF IOWA**  
 U/I Project Number:  
 20791  
 Project Number:  
 0116




**RONRBACH**  
**CARLSON PC**  
 ARCHITECTS  
 500 E. WASHINGTON  
 SUITE 400  
 IOWA CITY, IOWA 52242  
 TEL: 319.335.9311  
 FAX: 319.335.9311  
 E-MAIL: RCP@RONRBACH.COM

**CONSULTANTS:**  
 Mechanical/Electrical/Plumbing  
 The University of Iowa  
 1000 W. MICHIGAN  
 IOWA CITY, IOWA 52242  
 TEL: 319.335.9311  
 FAX: 319.335.9311  
 E-MAIL: RCP@RONRBACH.COM

**Sheet Title:**  
**SCHEMATIC**  
**FLOOR PLAN**  
**4-400 & 4-500**  
**CORES**  
**LEVEL 4**

**DATE:**   
**SCALE:** 1/4" = 1'-0"  
**DATE:**

**Drawn By:**  
 SWP  
**Checked By:**  
**Sheet Number:**

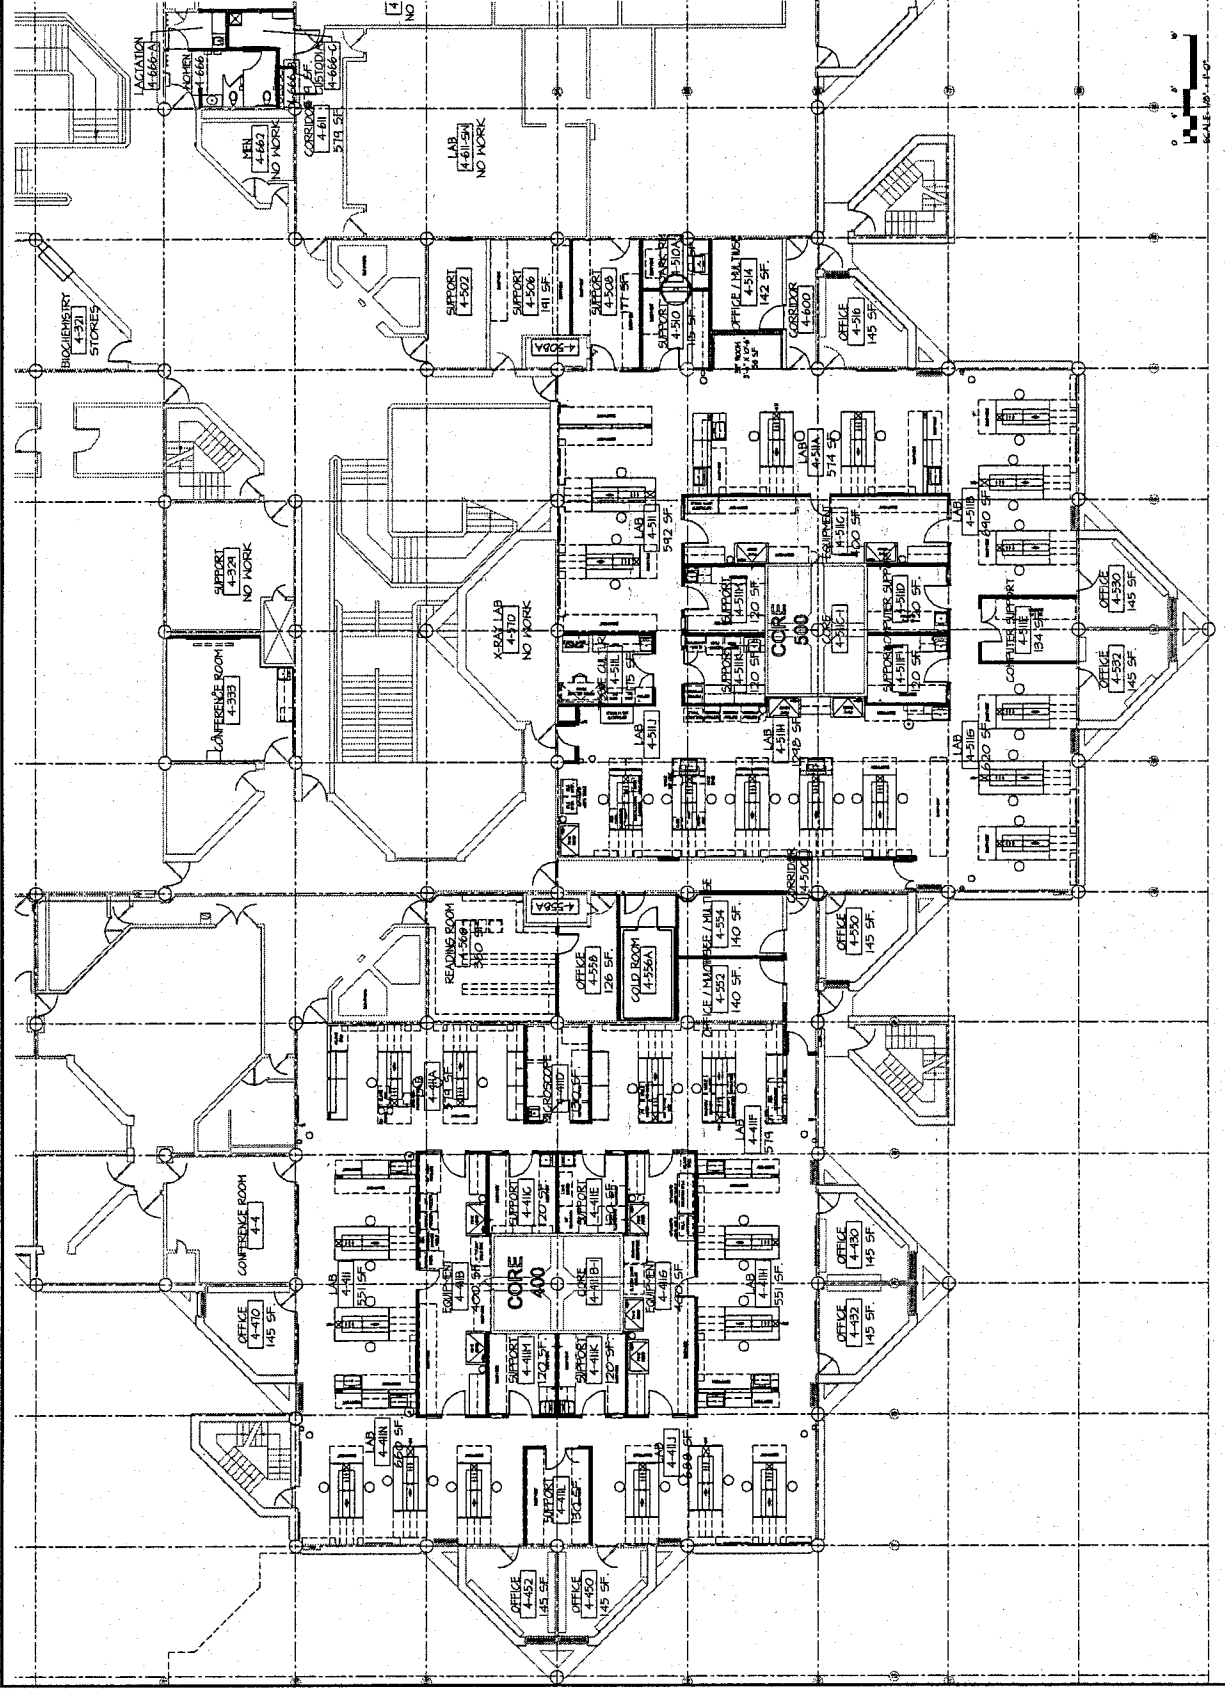

**Project Name:**  
**BOWEN**  
**SCIENCE**  
**BUILDING**  
 Remodeling  
 for  
 Biochemistry

**THE UNIVERSITY**  
**OF IOWA**

UI Project Number:  
 20731

Project Number:  
 0116



**RON RBACH**  
**CARLSON PC**

**ARCHITECTS**


CONTRACTOR: CARLSON  
 555 E. WASHINGTON  
 SUITE 400  
 IOWA CITY, IOWA 52242  
 TEL: 319 338 8877  
 FAX: 319 338 8873  
 CREDIT: CASH ON DELIVERY

**CONSULTANTS:**

**Independent Offices**  
 1000 University Ave., Suite 100  
 Iowa City, IA 52242  
 Tel: 319-335-3000  
 Fax: 319-335-3000

**ANNE and Associates, Inc.**  
 1000 University Ave., Suite 100  
 Iowa City, IA 52242  
 Tel: 319-335-3000  
 Fax: 319-335-3000

**Sheet Title:**  
**EXISTING**  
**FLOOR PLAN**  
**4-400 & 4-500**  
**CORES**  
**LEVEL 4**

Date:  N


SCALE 1/4" = 1'-0"

Date:

Drawn By: **SWP**

Checked By:

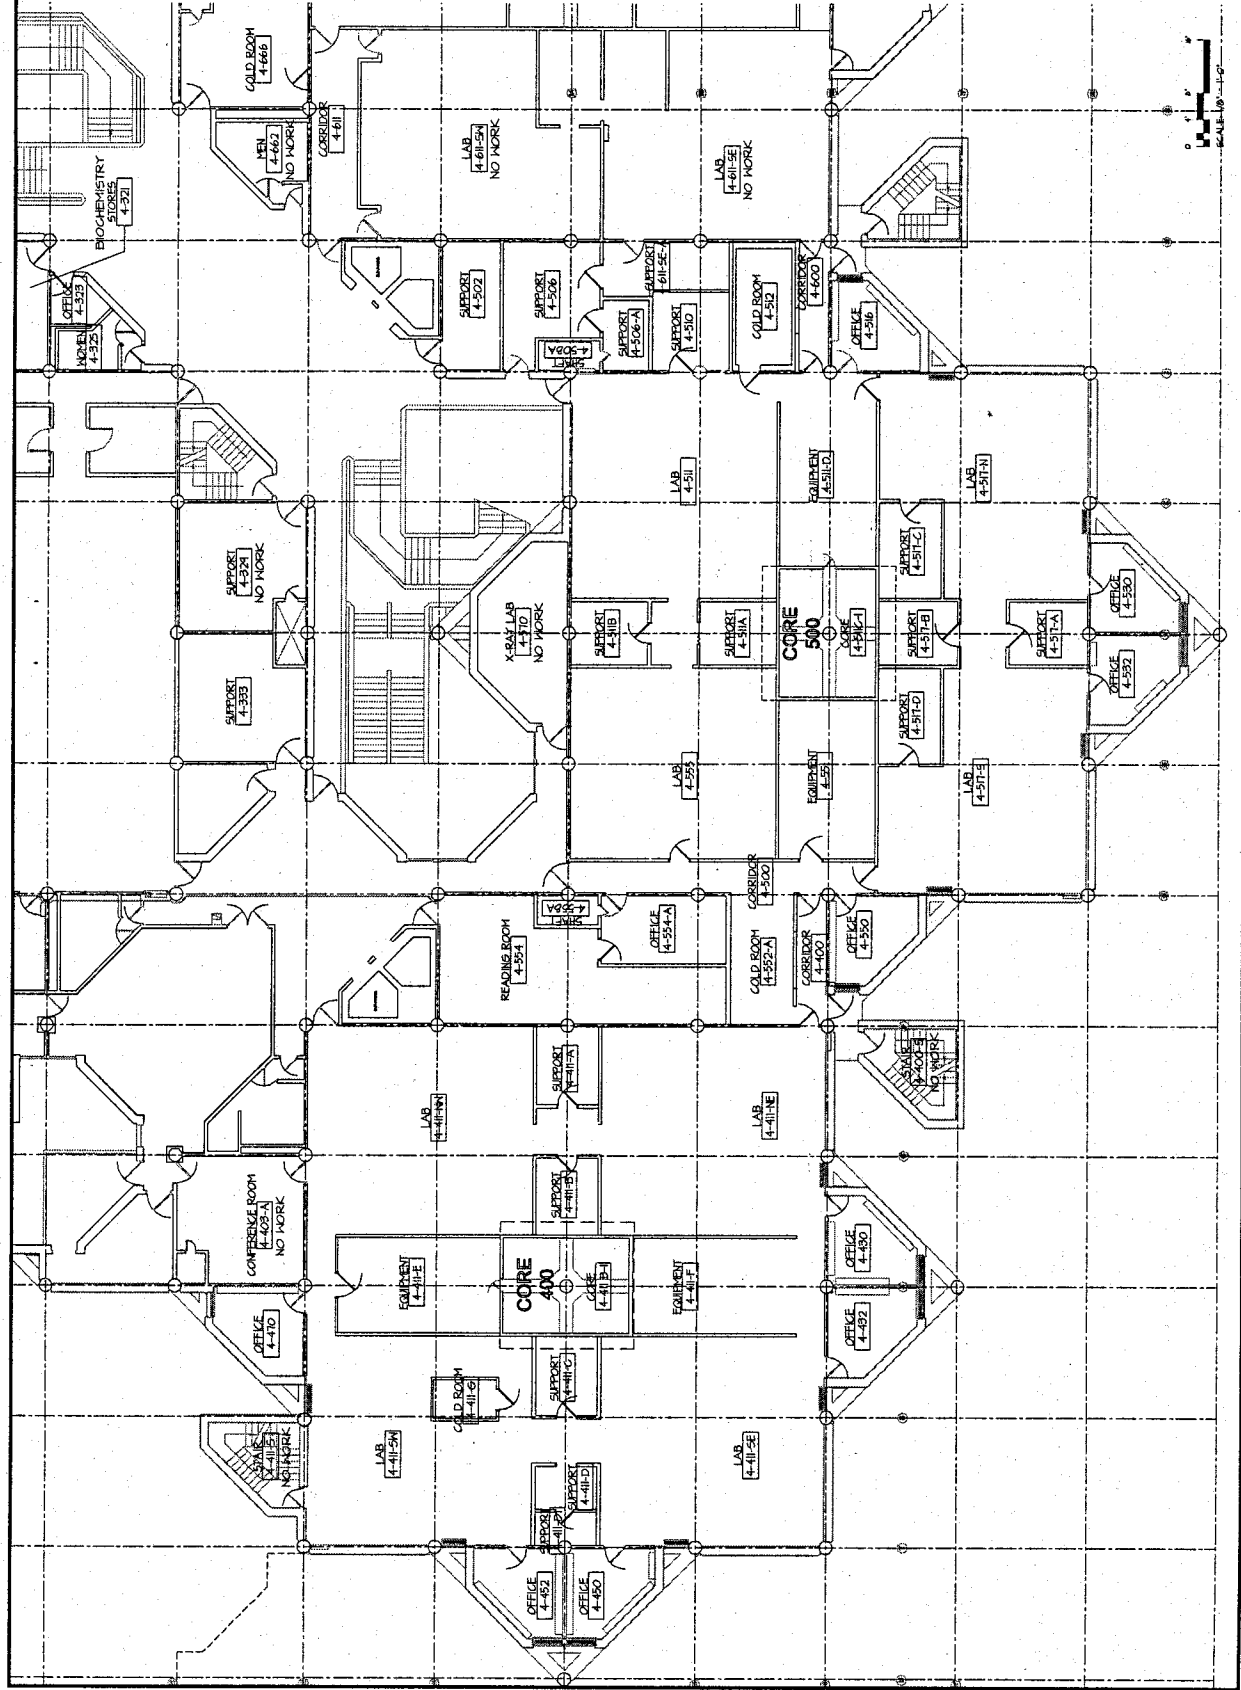

Sheet Number:






Scale: 1" = 300'  
PLOTTED 1-02-02

Legend

-  University Property Line
-  Chilled Water Loop

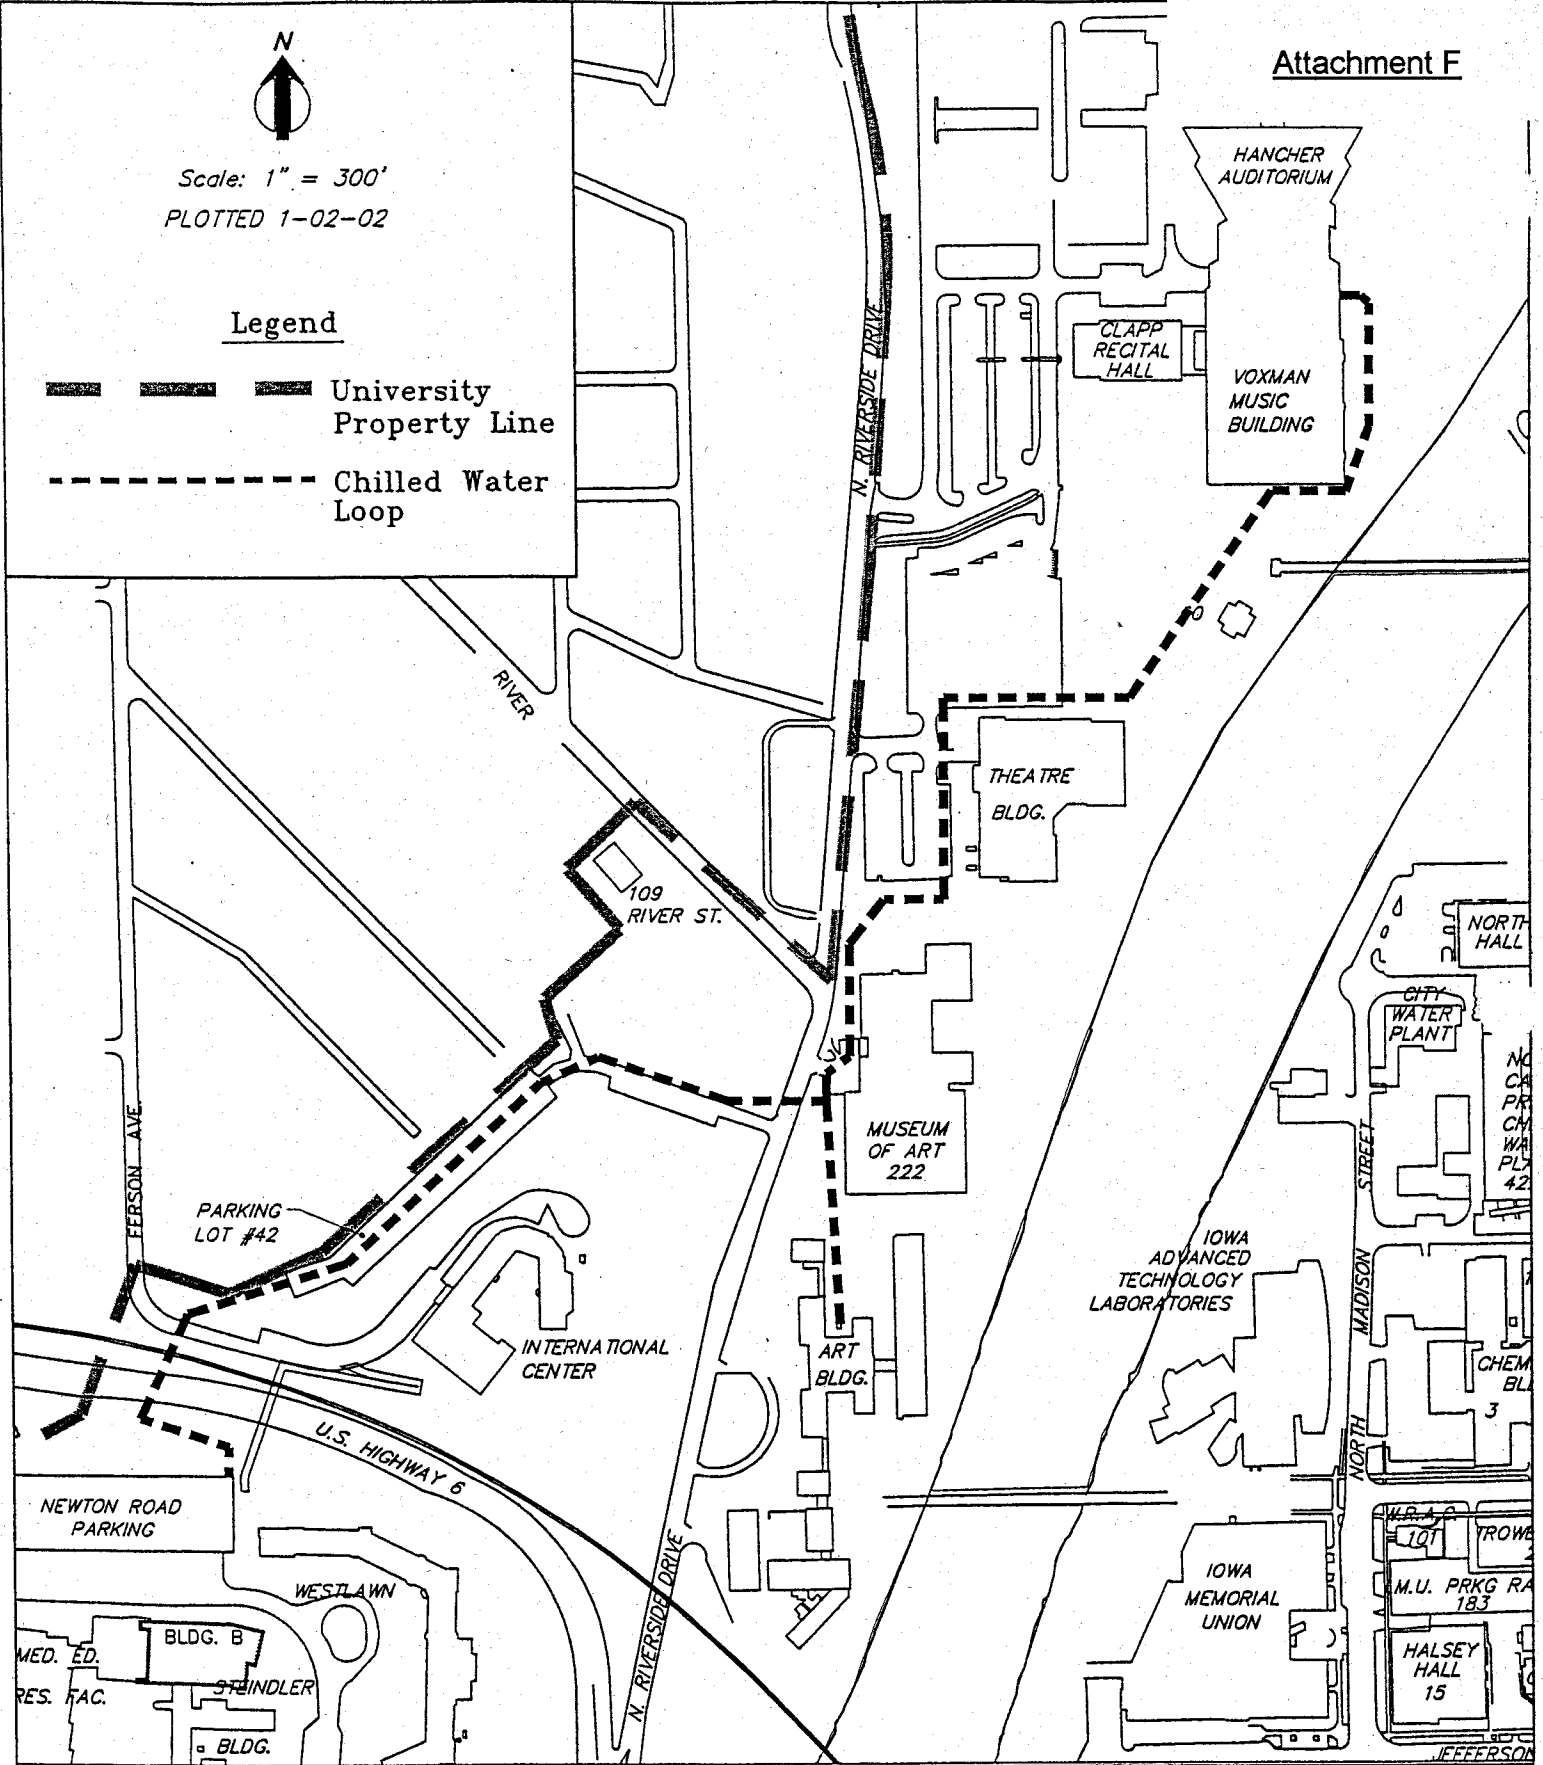

THE UNIVERSITY OF IOWA - LOCATION MAP

Iowa Center for the Arts Campus  
Central Chilled Water Distribution Piping  
and Parking Lot 42 Reconstruction

